

Municipal Information Renseignements municipaux

Return completed
form to:
Alcohol and Gaming
Commission of Ontario
90 Sheppard Avenue, East.
Suite 200
Toronto ON M2N 0A4

Remplir et retourner cette
formule à :
Commission des alcools
et des jeux de l'Ontario
90, avenue Sheppard Est
Bureau 200
Toronto ON M2N 0A4



The information requested below is required in support of all applications for a new liquor licence or outdoor areas being added to an existing liquor licence.

Les renseignements sont recueillis conjointement à toute demande de nouveau permis d'alcool ou d'ajout de zones de plein air à un permis d'alcool existant.

Section 1 - Application Details

Section 1 - Détails de la demande

Establishment name/Nom de l'établissement

Spoon and Fork Japanese Thai

Establishment tel. no./ N° de tél. de l'établissement

Contact name/Nom de la personne à contacter

Matthew Lam

Contact's tel. no./ N° de tél. de la personne à contacter

Exact location of establishment (not mailing address - street number and name, city or lot no., concession and township)

Emplacement exact de l'établissement (non l'adresse postale - numéro et nom de la rue, ville ou numéro de lot, concession et canton)

130 Park Place BLVD

Does the application for a liquor licence include:/La demande de permis d'alcool porte-t-elle entre autres sur :

☒ indoor areas/des zones intérieures ☐ outdoor areas/des zones de plein air

Section 2 - Municipal Clerk's official notice of application for a liquor licence in your municipality

Section 2 - Avis officiel de demande de permis d'alcool dans votre municipalité à l'intention du (de la) secrétaire municipal(e)

Municipal Clerk -
please confirm the "wet/damp/dry" status below.

Secrétaire municipal(e) :
Confirmer le statut de la région ci-dessous.

Name of village, town, township or city where taxes are paid/Nom du village, de la ville ou du canton à qui les impôts sont versés :

(If the area where the establishment is located was annexed or amalgamated, provide the name of the Village, Town, Township or City was known as)

(Si la région où se trouve l'établissement a été annexée ou fusionnée, nom sous lequel le village, la ville ou le canton était connu)

Is the area where the establishment is located:/ La vente de boissons alcooliques est-elle autorisée dans la région où se trouve l'établissement?

☒ Wet (for spirits, beer, wine)/Oui (spiritueux, bière, vin) ☐ Damp (for beer and wine only)/Oui (bière et vin seulement) ☐ Dry/Non

Note:

Specify concerns regarding zoning, non-compliance with bylaws, or general objections to the application by council or elected municipal representatives, must be clearly outlined, in a separate submission or letter within 30 days of this notification.

Remarque :

Toute question particulière concernant le zonage, la non-conformité aux règlements municipaux ou toute objection générale relative à la demande de la part de membres du conseil ou de représentants municipaux élus doit être décrite clairement dans un document distinct ou une lettre à l'intérieur d'une période de 30 jours après la remise du présent avis.

Signature of municipal official/Signature du (de la) représentant(e) municipal(e)

Title/Poste

Address of municipal office/Adresse du bureau municipal

Date

GENERAL INFORMATION

Name of Establishment: (Registered name and Operating name, if different)	2374183 Ontario Inc. Spoon and Fork Japanese Thai
Street Address of Establishment:	130 Park Place Blvd, Barrie
Closest Intersection:	Mapleview & Park Place
Mailing Address: (If different from the location of the establishment)	
Name of Owner: (Indicate individual sole proprietor, partnership or corporation, as appropriate) If partnership or corporation, provide names and contact information for all shareholders	2374183 Ontario Inc. Vivian Lok Yan Chong
Name of Applicant: (if different from owner)	Matthew Lam
Mailing Address for Applicant:	
Applicant Business Phone/Fax Number:	
Applicant Business E-mail address:	

Purpose of the Liquor Licence Application:

☒ New establishment

☐ New owner/operator of existing establishment

Name of previous business _____

☐ Change to indoor occupant load/seating capacity (including addition or alteration to interior)

☐ Change to outdoor occupant load/seating capacity (including addition or alteration to outdoor patio)

☐ Other. Describe below _____

SIZE AND LOCATION

What is the size (floor area) of the establishment?

CURRENT
Indoor Area

6517 ft²/m²

PROPOSED
Indoor Area

6517 ft²/m² *N/A*

CURRENT
Outdoor Area

1265 ft²/m²

PROPOSED
Outdoor Area

1265 ft²/m² *N/A*

What is the occupant load and/or seating capacity of the establishment?

CURRENT
Indoor Area

232
occupant load

232
licensed capacity

232
seating capacity

PROPOSED
Indoor Area

154
occupant load

154
licensed capacity

154
seating capacity

CURRENT
Outdoor Area

98
occupant load

98
licensed capacity

98
seating capacity

PROPOSED
Outdoor Area

98 *N/A*
occupant load

N/A
licensed capacity

N/A
seating capacity

Is the entire operation enclosed? (i.e. the operation is interior space only)

Yes _____ No ✓

An accurate diagram/scaled floor plan indicating the proposed location of the licensed area(s) (ALL licensed areas including indoor and outdoor areas) is required to be attached to this form.

What is the distance to the closest other establishment(s) serving alcohol? > 100 ft/m

Please provide the operating name(s) and describe the target market of other establishments serving alcohol within a 120 m (approximately 400 ft) radius of the proposed location:

WILD WING Family

Note: If you require more space please attach additional documentation to this form.

What is the distance to the closest residential dwelling unit? > 500 ft/m

Does the subject property contain residential units?

Yes _____ No ✓

OPERATING HOURS, TARGET MARKET, NATURE OF BUSINESS

Hours of Operation of the business: Sun - Thurs
11:30am - 10pm
Friday - Saturday
11:30 - 11pm

Hours associated with alcohol sales Indoor Area Outdoor Area

What is the primary nature of the establishment? (i.e. family restaurant, fine dining, lounge/nightclub, bar/tavern, coffee house, etc)

Before 10 PM:

Family Restaurant

After 10 PM:

Family Restaurant

Describe your target market:

family restaurant

Describe the proposed security both internally and exterior to the establishment (i.e. total number of staff, training or experience of staff, number of security persons):

Before 10 PM:

NONE

After 10 PM:

NONE

Note: If you require more space please attach additional documentation to this form.

Are all security personnel trained and licensed? Yes _____ No N/A Describe (i.e. in-house or hired service)

N/A

Note: If you require more space please attach additional documentation to this form.

Are exterior line ups (queues) anticipated for your establishment? Yes _____ No ✓

OPERATING HOURS, TARGET MARKET, NATURE OF BUSINESS (Continued)

Is either internal or external video surveillance planned for the establishment?

Yes ☒ No ☐ Describe

Video camera

Note: If you require more space please attach additional documentation to this form.

Describe your plans for crowd management:

Before 10 PM:

NONE

Note: If you require more space please attach additional documentation to this form.

After 10 PM:

NONE

Is a cover charge to enter the premises proposed? Yes ☐ No ☒ (routinely / special events)

What is the anticipated percentage of liquor sales to gross sales? 15%

OPERATING HOURS, TARGET MARKET, NATURE OF BUSINESS (Continued)

Describe the nature of the proposed seating for the venue (i.e. dining tables, cocktail tables, stand up bar):	Indoor Area <i>Dining table</i>
	Outdoor Area <i>" "</i>
Describe any food preparation facilities for the venue:	Indoor Area <i>Indoor Kitchen</i>
	Outdoor Area <i>N/A</i>
Describe any other type of business to be operated from the establishment on a permanent basis, or from time to time (i.e. bakeshop, variety store, grocery store, billiard hall, take-out restaurant, adult entertainment, non-motorized refreshment vehicles, etc?):	Indoor Area <i>N/A</i>
	Outdoor Area <i>N/A</i>
If yes, are the businesses physically separated from the licensed area(s) so that access or exits to and from the other business are not through the licensed area(s)? Provide full details:	Indoor Area <i>N/A</i>
	Outdoor Area <i>N/A</i>
Describe any ancillary entertainment (i.e. video games, pool tables, etc):	Indoor Area <i>N/A</i>
	Outdoor Area <i>N/A</i>

OPERATING HOURS, TARGET MARKET, NATURE OF BUSINESS (Continued)

Describe any musical entertainment to be provided (i.e. dance floor, live/recorded music, amplified sound , etc)	<u>Indoor Area Only</u> Dance Floor Yes _____ No <u>✓</u> Live Music Yes _____ No <u>✓</u> Recorded Music Yes <u>✓</u> No _____ Amplified Sound Yes <u>✓</u> No _____ Unamplified Sound Yes _____ No <u>✓</u>
	<u>Outdoor Area Only</u> Dance Floor Yes _____ No <u>✓</u> Live Music Yes _____ No <u>✓</u> Recorded Music Yes <u>✓</u> No _____ Amplified Sound Yes <u>✓</u> No _____ Unamplified Sound Yes _____ No <u>✓</u>

OWNERSHIP/MANAGEMENT INFORMATION

Describe the owner or operator's performance record including any by-law violations, building, health, fire code deficiencies noted on an inspection report, and any pending charges or convictions or liquor licence offences within the last 3 years:

NIL

Has a principal officer of the business or a manager of the business been charged with or convicted of a liquor licence related offence? Yes _____ No ☒ If yes, provide details of any pending charge or conviction

Do any of the principal officer(s) or managers of the business have a criminal record? Yes _____ No ☒ If yes, provide a copy of the criminal records check

Is there a pending charge or conviction against the business related to a liquor related offence? Yes _____ No ☒ If yes, provide details

List the names and addresses of any other licensed establishments in Canada owned or operated by the same operator or owner:

Spoon and Fork PLUS
865 Yorkmills Road Toronto

Note: If you require more space please attach additional documentation to this form.

I MATTHEW LAM (name of applicant/owner), hereby certify that the information provided pursuant to this liquor licence application questionnaire is true, accurate and complete to the best of my knowledge and ability. I understand and acknowledge that if the information with respect to the establishment changes materially, I am responsible for completing and submitting an updated questionnaire. I further understand and acknowledge that the submission of an incomplete questionnaire or the inclusion of false statements is deemed to be a breach of any business licence issued by the City and may be grounds for such licence to be revoked.

Matthew Lam

Signature of Applicant

Sworn (Affirmed) before me at The City of Barrie,
in the Province of Ontario on the 25th day

APRIL, 20 17.

Heather Jane Cassis
A Commissioner, etc.

Heather Jane Cassis, a
Commissioner, etc., Province of
Ontario, for the Corporation of
the City of Barrie.
Expires July 19, 2018.

NOTE: This is a sworn (affirmed) affidavit of the deponent only. No investigation has been conducted by this authority to confirm or verify the above sworn information.

The CRIMINAL CODE OF CANADA provides that: everyone commits perjury who, with intent to mislead, makes before a person who is authorized by law to permit it to be made before him a false statement under oath or solemn affirmation by affidavit, solemn declaration or deposition or orally, knowing that the statement is false, is guilty of an indictable offence and liable to a term of imprisonment not exceeding fourteen years (Section 131, 132), or by summary conviction (Section 134).

Personal information on this form is collected to determine any concerns with zoning, non-compliance with any by-laws or general objections to the application by City Council, the municipality, residents, and/or organizations within the municipality. The document and any associated submissions will be made available on the City's website and distributed to various stakeholder organizations and resident associations as well as the Alcohol and Gaming Commission of Ontario. This document is a public record, despite anything in the *Municipal Freedom of Information and Protection of Privacy Act (1990)*, and, until its destruction, may be inspected by any person at the City Clerk's Office at a time when the office is open. Questions about this collection can be directed to the City Clerk, 70 Collier Street, Barrie, Ontario L4M 4T5 (705) 739-4220 Ext 4421.

130 PARK PLACE BLVD.,

130 PARK PLACE BLVD.,
BARRIE, ONTARIO



SITE / KEY PLAN

- Adding a Sushi Preparation Area
- Adjust sealing in the existing dining area (occupant load remains)
- Minor plumbing work (adding one floor drain and one sink)
- Existing washroom facilities remains
- Existing exiting remains
- Existing Kitchen and its hood system remains
- Existing HVAC system remains
- Existing fire alarm system remains

Items	Ontario's PMU Training Code			Data Entry Tab 3		PMU Reference	
	Project Description	□ Day 1 Use	□ Day 2 Use	□ Day 1 Use	□ Day 2 Use	□ Day 1 Use	□ Day 2 Use
1	Project Description	□ Day 1 Use	□ Day 2 Use	□ Day 1 Use	□ Day 2 Use	□ Day 1 Use	□ Day 2 Use
2	Project Description	□ Day 1 Use	□ Day 2 Use	□ Day 1 Use	□ Day 2 Use	□ Day 1 Use	□ Day 2 Use
3	Project Description	□ Day 1 Use	□ Day 2 Use	□ Day 1 Use	□ Day 2 Use	□ Day 1 Use	□ Day 2 Use
4	Project Description	□ Day 1 Use	□ Day 2 Use	□ Day 1 Use	□ Day 2 Use	□ Day 1 Use	□ Day 2 Use
5	Project Description	□ Day 1 Use	□ Day 2 Use	□ Day 1 Use	□ Day 2 Use	□ Day 1 Use	□ Day 2 Use
6	Project Description	□ Day 1 Use	□ Day 2 Use	□ Day 1 Use	□ Day 2 Use	□ Day 1 Use	□ Day 2 Use
7	Project Description	□ Day 1 Use	□ Day 2 Use	□ Day 1 Use	□ Day 2 Use	□ Day 1 Use	□ Day 2 Use
8	Project Description	□ Day 1 Use	□ Day 2 Use	□ Day 1 Use	□ Day 2 Use	□ Day 1 Use	□ Day 2 Use
9	Project Description	□ Day 1 Use	□ Day 2 Use	□ Day 1 Use	□ Day 2 Use	□ Day 1 Use	□ Day 2 Use
10	Project Description	□ Day 1 Use	□ Day 2 Use	□ Day 1 Use	□ Day 2 Use	□ Day 1 Use	□ Day 2 Use
11	Project Description	□ Day 1 Use	□ Day 2 Use	□ Day 1 Use	□ Day 2 Use	□ Day 1 Use	□ Day 2 Use
12	Project Description	□ Day 1 Use	□ Day 2 Use	□ Day 1 Use	□ Day 2 Use	□ Day 1 Use	□ Day 2 Use
13	Project Description	□ Day 1 Use	□ Day 2 Use	□ Day 1 Use	□ Day 2 Use	□ Day 1 Use	□ Day 2 Use
14	Project Description	□ Day 1 Use	□ Day 2 Use	□ Day 1 Use	□ Day 2 Use	□ Day 1 Use	□ Day 2 Use
15	Project Description	□ Day 1 Use	□ Day 2 Use	□ Day 1 Use	□ Day 2 Use	□ Day 1 Use	□ Day 2 Use
16	Project Description	□ Day 1 Use	□ Day 2 Use	□ Day 1 Use	□ Day 2 Use	□ Day 1 Use	□ Day 2 Use
17	Project Description	□ Day 1 Use	□ Day 2 Use	□ Day 1 Use	□ Day 2 Use	□ Day 1 Use	□ Day 2 Use
18	Project Description	□ Day 1 Use	□ Day 2 Use	□ Day 1 Use	□ Day 2 Use	□ Day 1 Use	□ Day 2 Use
19	Project Description	□ Day 1 Use	□ Day 2 Use	□ Day 1 Use	□ Day 2 Use	□ Day 1 Use	□ Day 2 Use

— Sales From Properties Per OTC

CITY OF DARTMOUTH
RECEIVED
SEP 16 1985
BUILDING
SERVICES

	GENERAL NOTES AND CONDITIONS Do not scale drawings. This drawing is for the information of owner and contractor, and for the purpose of the C.C. work. It is not to be used for construction, and the contractor is responsible for the design and construction of the building. The contractor shall be responsible for the design and construction of the building. The contractor shall be responsible for the design and construction of the building.		Revision No. Date A 08/09/16	Description PERMIT APPLICATION	Project: INTERIOR RENOVATION OF AN EXISTING RESTAURANT 130 PARK PLACE BLVD, BARRIE, ONTARIO	Project No. SF-01-16 Scale N/C Approved By G.C. Drawn By G.C. Date SEPT. 08, 16 Checked by G.C. Drawing No. C-1
	Drawing Title: SITE PLAN / BUILDING MATRIX					


GENERAL NOTES AND CONDITIONS
1. The owner warrants that the information provided in the application is true and correct to the best of their knowledge and belief.
2. The owner warrants that the information provided in the application is true and correct to the best of their knowledge and belief.
3. The owner warrants that the information provided in the application is true and correct to the best of their knowledge and belief.

No.	Date	Description
1	08/09/16	PERMIT APPLICATION



Project: INTERIOR RENOVATION OF AN EXISTING RESTAURANT
130 PARK PLACE BLVD.,
BARRIE, ONTARIO

FLOOR / PARTITION LAYOUT

Project No. SF-01-16
Scale: N/C
Drawn By: G.C.
Date: SEPT. 08, 16
Discipline: G.C.
Drawing No. A-1

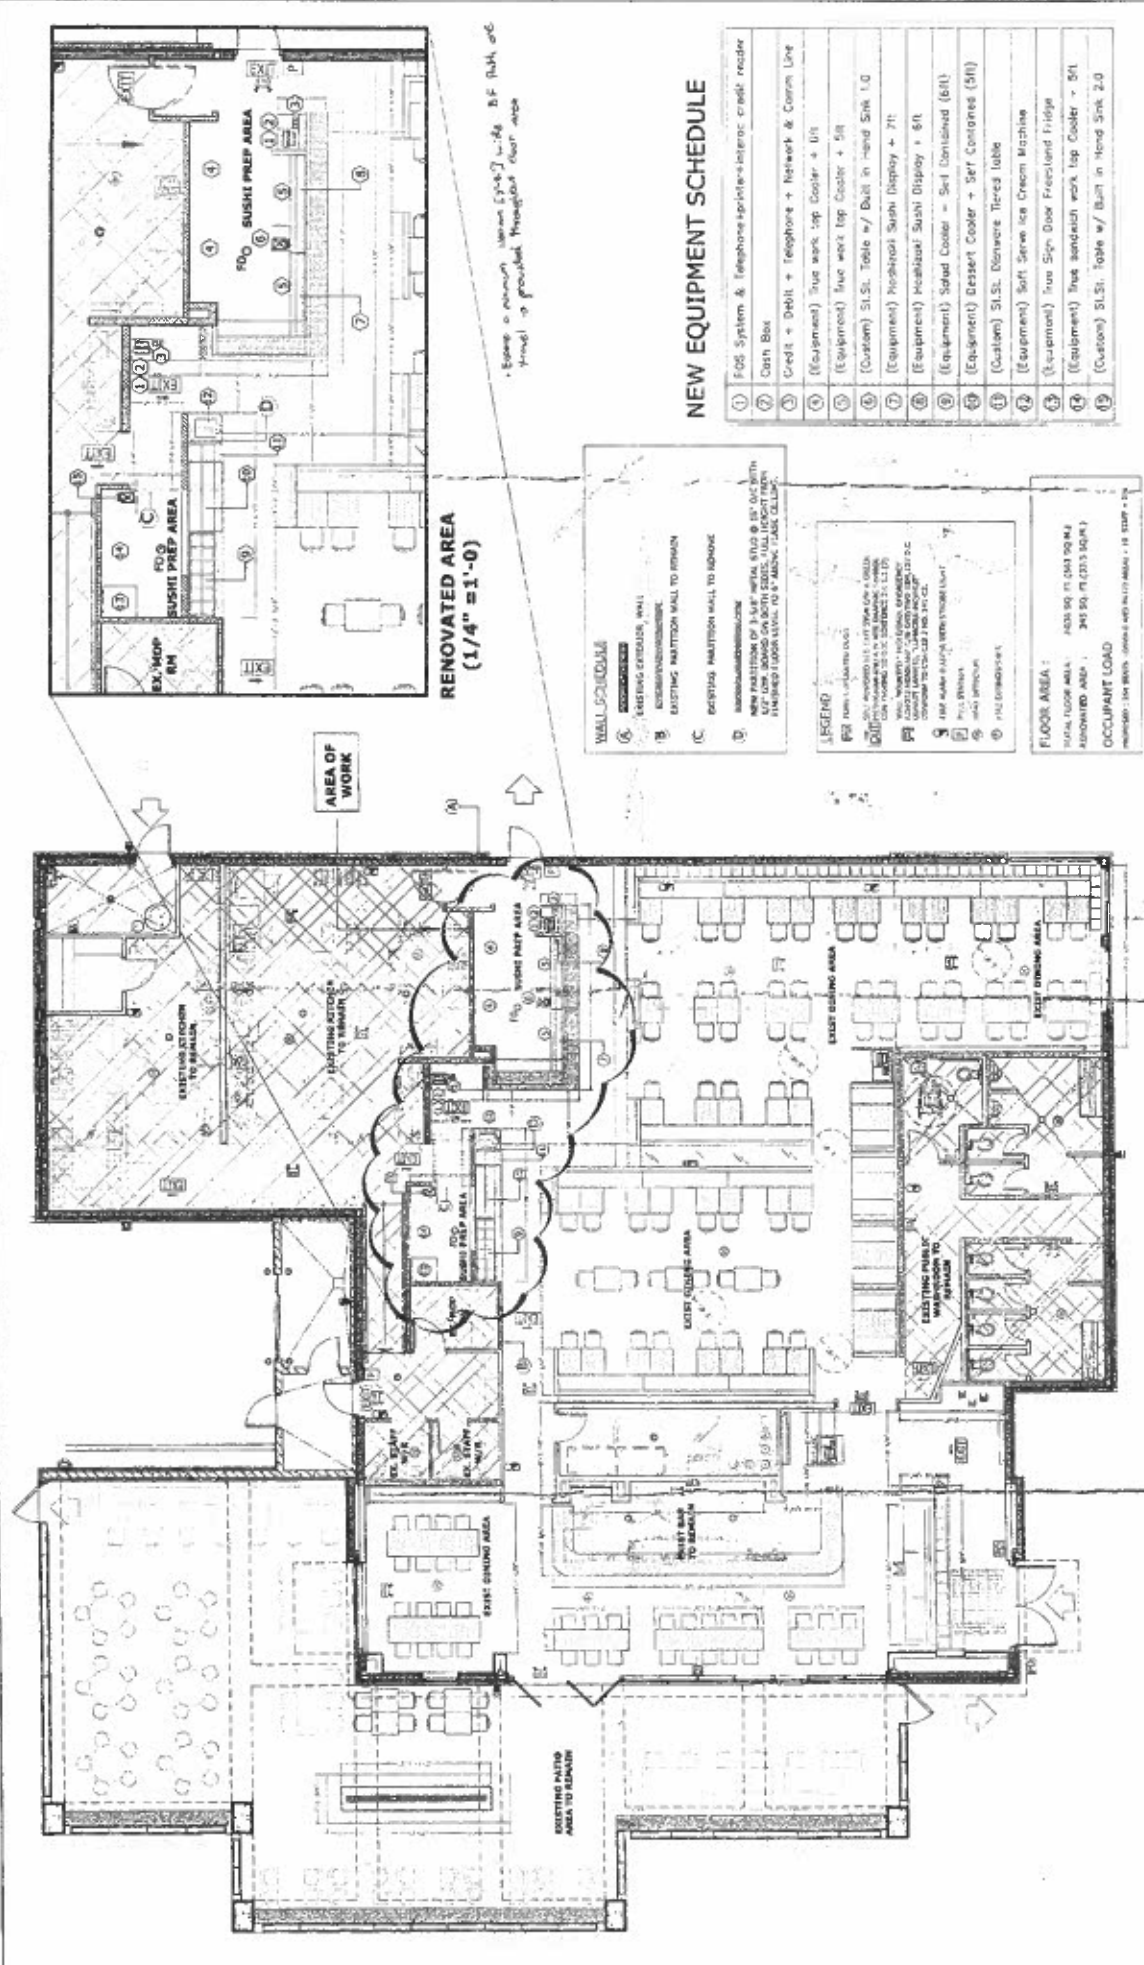

Some of the items shown [?] will be B.F. [?] and [?] to provide [?] [?]

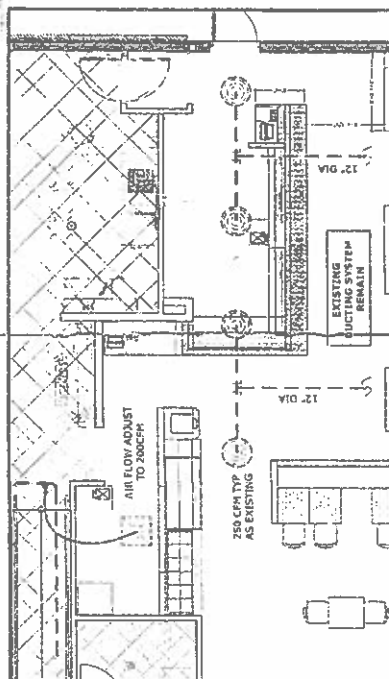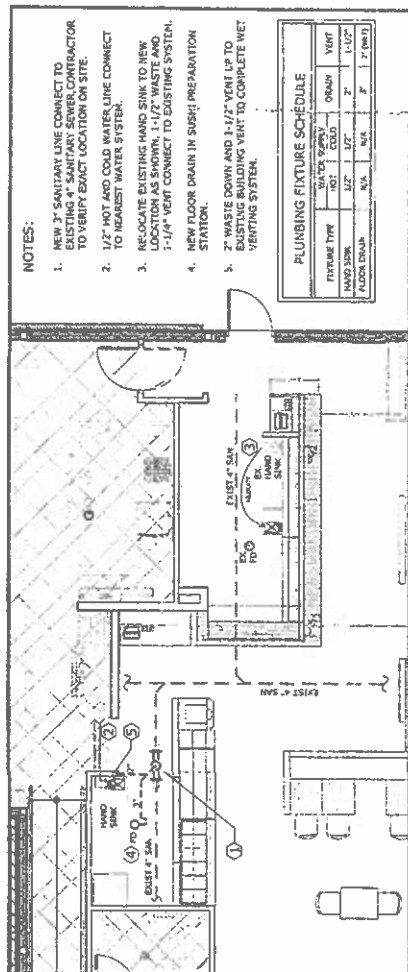

PLUMBING FIXTURE SCHEDULE				
FIXTURE TYPE	WATER SUPPLY		DRAIN	VENT
	W.H.I.	COLD		
WASH SINK	1/2"	1/2"	2"	1-1/2"
FLOOR DRAIN	N/A	N/A	3"	2" (min.)

NOTES:

1. NEW 2" SANITARY LINE CONNECT TO EXISTING 4" SANITARY SEWER CONTRACTOR TO VERIFY EXACT LOCATION ON SITE.
2. 1/2" HOT AND COLD WATER LINE CONNECT TO NEAREST WATER SYSTEM.
3. RE-LOCATE EXISTING HAND SINK TO NEW LOCATION AS SHOWN, 1-1/2" WASTE AND 1-1/4" VENT CONNECT TO EXISTING SYSTEM.
4. NEW FLOOR DRAIN IN SUSHI PREPARATION STATION.
5. 2" WASTE DOWN AND 1-1/2" VENT UP TO EXISTING BUILDING VENT TO COMPLETE WET VENTING SYSTEM.

PLUMBING AND DRAINAGE SYSTEM (1/4"=1'-0")

MECHANICAL / HVAC SYSTEM (1/4" = 1'-0")

General Construction and Partition Notes:

1. All work to be done must comply with the requirements of the relevant standards and codes including those relating to fire, structural and environmental.
2. Whilst this drawing is in preparation you shall submit to the project manager a programme of work detailing the sequence of construction and the anticipated completion dates for each element of the project. This programme shall be submitted to the project manager for approval and shall be subject to the project manager's comments and instructions.
3. The contractor shall be responsible for obtaining all necessary permits and approvals from the authorities having jurisdiction over the project.
4. The contractor shall be responsible for obtaining all necessary permits and approvals from the authorities having jurisdiction over the project.
5. The contractor shall be responsible for obtaining all necessary permits and approvals from the authorities having jurisdiction over the project.
6. The contractor shall be responsible for obtaining all necessary permits and approvals from the authorities having jurisdiction over the project.
7. The contractor shall be responsible for obtaining all necessary permits and approvals from the authorities having jurisdiction over the project.
8. The contractor shall be responsible for obtaining all necessary permits and approvals from the authorities having jurisdiction over the project.
9. The contractor shall be responsible for obtaining all necessary permits and approvals from the authorities having jurisdiction over the project.
10. The contractor shall be responsible for obtaining all necessary permits and approvals from the authorities having jurisdiction over the project.
11. The contractor shall be responsible for obtaining all necessary permits and approvals from the authorities having jurisdiction over the project.
12. The contractor shall be responsible for obtaining all necessary permits and approvals from the authorities having jurisdiction over the project.
13. The contractor shall be responsible for obtaining all necessary permits and approvals from the authorities having jurisdiction over the project.
14. The contractor shall be responsible for obtaining all necessary permits and approvals from the authorities having jurisdiction over the project.
15. The contractor shall be responsible for obtaining all necessary permits and approvals from the authorities having jurisdiction over the project.
16. The contractor shall be responsible for obtaining all necessary permits and approvals from the authorities having jurisdiction over the project.
17. The contractor shall be responsible for obtaining all necessary permits and approvals from the authorities having jurisdiction over the project.
18. The contractor shall be responsible for obtaining all necessary permits and approvals from the authorities having jurisdiction over the project.
19. The contractor shall be responsible for obtaining all necessary permits and approvals from the authorities having jurisdiction over the project.
20. The contractor shall be responsible for obtaining all necessary permits and approvals from the authorities having jurisdiction over the project.

PULPING SPECIFICATIONS

- * During installation shall be in accordance with Ontario Building Code Part 7 and local authority having jurisdiction.
- * Floor cutting and sealing job will be coordinated with the landlord.
- * Provide way if necessitated when required by tradesmen.
- * General specification and the best building standards and specifications shall apply to this job up to and including in full.
- * The first two (2) of all building equipments and fixtures shall be by this plumbing contractor. All other materials and material shall be non commensal grade unless otherwise noted
- * Above ground plumbing and drainage contractor shall be responsible for proper installation of the system in advance of concrete pouring or similar work. He shall provide and set elements where required. This general contracteer will provide the mechanical knowledge. If this provision fails to support the work of the trade, this contractor shall be responsible for all costs related to the extra work. At varying and existing shall be performed by the General Contractor only.
- * Above ground plumbing and drainage contractor shall provide all plumbing works shown or implied on the drawings. The contractors shall commence with connection between the main sewer and the building sewer. The contractor shall provide the drainage contractor and created by the final installation of fixtures. Such work will be provided for inline solutions by the underground plumbing and drainage contractor. The contractor of basement shall be by the above ground plumbing and drainage contractor.
- * Proposed design shall be verified before commencement of any work including building floor, ceiling and structural work, columns and steel elevations. The location indicated is approximate only.
- * Provide accessible shut-off valves on domestic hot and cold water supplies at all fixtures and equipments. Provide backflow preventers on equipment connections
- * Plumbing fittings shall be as follows or approved equal:
 - (Floor Drain) = Envocon E L000849A (Patched Area)
 - (Sinks) = Envocon E L000849B (Patched Area)
 - (Clean out) = Fiproco F 3000297 (Three Area)
 - (Drain out) = Envocon E 300067K (Unpatched area)
 - (Water closet) = Envocon E 300067K (Unpatched area)
 - (Hot Drain) = Envocon E L30000
- * Trip seal primer = maxon HS-GLD
- * P-trap seal drain oil clean out
- * Includes all test and check water pipes, storm piping, scum and condensation with 1/2" barrier. Barriers are not to be added.
- * All hot and cold water, waste pipe and condensates & vents to plumbing fixtures must be completed in sizes stated per drawings.

Check up of Size

13. The general contractor shall be responsible to keep all landward access ways clear (i.e., no debris, materials, equipment and other obstructions) and as required upon completion of the work, remove them. The general contractor shall remove all protective materials. The general contractor shall have a professional chain service to vacuum down the carpet, clean the walls, curtains, windows sills and vacuum down the railwork.
16. Access to the site for material, work forces a bid for garbage removal is to be coordinated with building management office.

* Use medium weight cast iron for sanitary sewer pipes with mechanical joints, buried either inside new building shafts or CSA approved ABS plastic D 181-1. Use type A copper for buried water pipes. Use type II copper pipe to ASTM-88 std with solder fittings above grade. All piping must be supported as per code requirements. Use copper tubing (DWV) or galvanized steel for vents. Use cast iron through roof.

* Rice openings in floors, walls and roof shall be packed with glass fiber insulation after installation of piping. (Final sealing of fire retard walls and floors to be co-ordinated with construction superintendent.)

* Only lead free solder is to be used

Install polished chrome escutcheon plates on all doors where they pass through walls or ceilings in finished areas. Provide flashing and counter-flashing for all equipments, piping etc. passing through the roof, wall, etc.

Natural gas system shall be installed in conformance with Natural Gas Installation Code CNG/CGA-81-95 latest edition. Natural gas piping shall be schedule 40 black steel pipe conforming to ASTM A-53 grade B with accessible iron screwed fitting. Valves shall be backseat-tightroom Fig. 142 or equal, lubricated, plug valves. Piping shall be continuous weld for 3" diameter and

under, electric resistance vessel for 6" diameter and over.

Obtain copy of kitchen equipment schedule from owner/general contractor, and ensure all plumbing connections to the equipment for a complete system.

Above ground plumbing and drainage contractor shall provide water meter with remote readout (if required) as necessary in the building system. A 3 valve bypass for water meter 3.5 per local municipal/resolution standards.

Provide plumbing fixtures shop drawings to designer for approval before ordering. Fixtures shall be supplied with all accessories (sinks, escutcheons etc.) that are required for complete installation.

As excavating and backfilling for mechanical work is to be included in the Contract, including excavation, removal of excavated soil, supply of proper backfill materials, etc.

Subsequent to this, all relevant joining between condensing units and refrigerant piping (3/8" and 1/2" diameter) shall be welded in place and the HVAC unit manufacturer for a complete system. All elbows and fittings shall be brazed with silver brazing. All brazing shall be done in accordance with ASHRAE 15-85 Striker's approval. After complete unit fittings shall be made with 5/16" stainless steel tubing. The entire piping system shall be tested with nitrogen. Pressure to 150 psi on vacuum line for 12 hours. Provide 1/2" schedule 40 steel with Armco's insulation, with proper tie and anchor ratings, on all suction lines.

SPOON & FORK 日本 JAPANESE-THAI 日本





GENERAL NOTES AND CONDITIONS

We will supply design, construction, and instruments of supply, and consulting, at the price of \$400.00 per hour. The fee for design and construction is \$400.00 per hour. The fee for instruments of supply and consulting is \$400.00 per hour. The fee for design and construction is \$400.00 per hour. The fee for instruments of supply and consulting is \$400.00 per hour.

Contractor shall obtain and verify all information from the engineer. The engineer shall not be responsible for any errors or omissions in the drawings or specifications. The contractor shall be responsible for any errors or omissions in the drawings or specifications.

The drawings shall be prepared in accordance with the specifications. The contractor shall be responsible for any errors or omissions in the drawings or specifications.

Project:

**130 PARK PLACE BLVD,
BARRIE, ONTARIO**

Project No. SF-01-16

Scale AS SHOWN

Tracer By G.C.

Checked By G.C.

Date SEPT. 08, 16

Drawing No. M&P-1

Project:

**130 PARK PLACE BLVD,
BARRIE, ONTARIO**

Project No. SF-01-16

Scale AS SHOWN

Tracer By G.C.

Checked By G.C.

Date SEPT. 08, 16

Drawing No. M&P-1

Project:

**130 PARK PLACE BLVD,
BARRIE, ONTARIO**

Project No. SF-01-16

Scale AS SHOWN

Tracer By G.C.

Checked By G.C.

Date SEPT. 08, 16

Drawing No. M&P-1

Project:

**130 PARK PLACE BLVD,
BARRIE, ONTARIO**

Project No. SF-01-16

Scale AS SHOWN

Tracer By G.C.

Checked By G.C.

Date SEPT. 08, 16

Drawing No. M&P-1

Project:

**130 PARK PLACE BLVD,
BARRIE, ONTARIO**

Project No. SF-01-16

Scale AS SHOWN

Tracer By G.C.

Checked By G.C.

Date SEPT. 08, 16

Drawing No. M&P-1

Project:

**130 PARK PLACE BLVD,
BARRIE, ONTARIO**

Project No. SF-01-16

Scale AS SHOWN

Tracer By G.C.

Checked By G.C.

Date SEPT. 08, 16

Drawing No. M&P-1

Project:

**130 PARK PLACE BLVD,
BARRIE, ONTARIO**

Project No. SF-01-16

Scale AS SHOWN

Tracer By G.C.

Checked By G.C.

Date SEPT. 08, 16

Drawing No. M&P-1

Project:

**130 PARK PLACE BLVD,
BARRIE, ONTARIO**

Project No. SF-01-16

Scale AS SHOWN

Tracer By G.C.

Checked By G.C.

Date SEPT. 08, 16

Drawing No. M&P-1

Project:

**130 PARK PLACE BLVD,
BARRIE, ONTARIO**

Project No. SF-01-16

Scale AS SHOWN

Tracer By G.C.

Checked By G.C.

Date SEPT. 08, 16

Drawing No. M&P-1

Project:

**130 PARK PLACE BLVD,
BARRIE, ONTARIO**

Project No. SF-01-16

Scale AS SHOWN

Tracer By G.C.

Checked By G.C.

Date SEPT. 08, 16

Drawing No. M&P-1

Project:

**130 PARK PLACE BLVD,
BARRIE, ONTARIO**

Project No. SF-01-16

Scale AS SHOWN

Tracer By G.C.

Checked By G.C.

Date SEPT. 08, 16

Drawing No. M&P-1

Project:

**130 PARK PLACE BLVD,
BARRIE, ONTARIO**

Project No. SF-01-16

Scale AS SHOWN

Tracer By G.C.

Checked By G.C.

Date SEPT. 08, 16

Drawing No. M&P-1

Project:

**130 PARK PLACE BLVD,
BARRIE, ONTARIO**

Project No. SF-01-16

Scale AS SHOWN

Tracer By G.C.

Checked By G.C.

Date SEPT. 08, 16

Drawing No. M&P-1

Project:

**130 PARK PLACE BLVD,
BARRIE, ONTARIO**

Project No. SF-01-16

Scale AS SHOWN

Tracer By G.C.

Checked By G.C.

Date SEPT. 08, 16

Drawing No. M&P-1

Project:

**130 PARK PLACE BLVD,
BARRIE, ONTARIO**

Project No. SF-01-16

Scale AS SHOWN

Tracer By G.C.

Checked By G.C.

Date SEPT. 08, 16

Drawing No. M&P-1

Project:

**130 PARK PLACE BLVD,
BARRIE, ONTARIO**

Project No. SF-01-16

Scale AS SHOWN

Tracer By G.C.

Checked By G.C.

Date SEPT. 08, 16

Drawing No. M&P-1

Project:

**130 PARK PLACE BLVD,
BARRIE, ONTARIO**

Project No. SF-01-16

Scale AS SHOWN

Tracer By G.C.

Checked By G.C.

Date SEPT. 08, 16

Drawing No. M&P-1

Project:

**130 PARK PLACE BLVD,
BARRIE, ONTARIO**

Project No. SF-01-16

Scale AS SHOWN

Tracer By G.C.

Checked By G.C.

Date SEPT. 08, 16

Drawing No. M&P-1

Project:

**130 PARK PLACE BLVD,
BARRIE, ONTARIO**

Project No. SF-01-16

Scale AS