



Bill No. 118

BY-LAW NUMBER 2012-

A By-law of The Corporation of the City of Barrie to amend By-law 89-86 being a by-law to designate private roadways as Emergency Fire Routes along which no parking of vehicles shall be permitted.

WHEREAS, pursuant to the Fire and Protection Act, 1997, S.O. 1997, C.4, s.7.1.(1)(c) the Council of any municipality may designate private roadways as emergency fire routes along which no parking of vehicles shall be permitted;

AND WHEREAS, the Council of The Corporation of the City of Barrie adopted By-law 89-86 being a by-law to designate private roadways as emergency fire routes along which no parking of vehicles shall be permitted;

AND WHEREAS, by motion 05-G-514, it is deemed expedient that the Council of The Corporation of the City of Barrie amend By-law 89-86, as amended, being a by-law to designate private roadways as emergency fire routes along which no parking of vehicles shall be permitted.

AND WHEREAS Section 9 of the Municipal Act, 2001, provides that Sections 8 and 11 shall be interpreted broadly so as to confer broad authority on municipalities to (a) enable municipalities to govern their affairs as they consider appropriate and, (b) enhance their ability to respond to municipal issues;

NOW THEREFORE the Council of The Corporation of the City of Barrie enacts as follows:

1. **THAT** By-law 89-86 be amended by adding Schedule 232 attached hereto as Schedule "A" designating an emergency fire route at 505 Bayview Drive, Barrie (IBM Canada Ltd.).
2. **THAT** By-law 89-86 be amended by adding Schedule 233 attached hereto as Schedule "B" designating an emergency fire route at 91 Coughlin Road, Barrie (Simcoe Condominium Corporation #336).
3. **THAT** this By-law shall come into force and effect immediately upon the final passing thereof.

READ a first and second time this 27th day of August, 2012.

READ a third time and finally passed this 27th day of August, 2012.


THE CORPORATION OF THE CITY OF BARRIE

MAYOR - J. LEHMAN

CITY CLERK – DAWN A. MCALPINE

I.B.M. CANADA LTD
505 BAYVIEW DRIVE
BARRIE

PLAN BAYVIEW DRIVE INTER SECTION
SCALE: 1:300

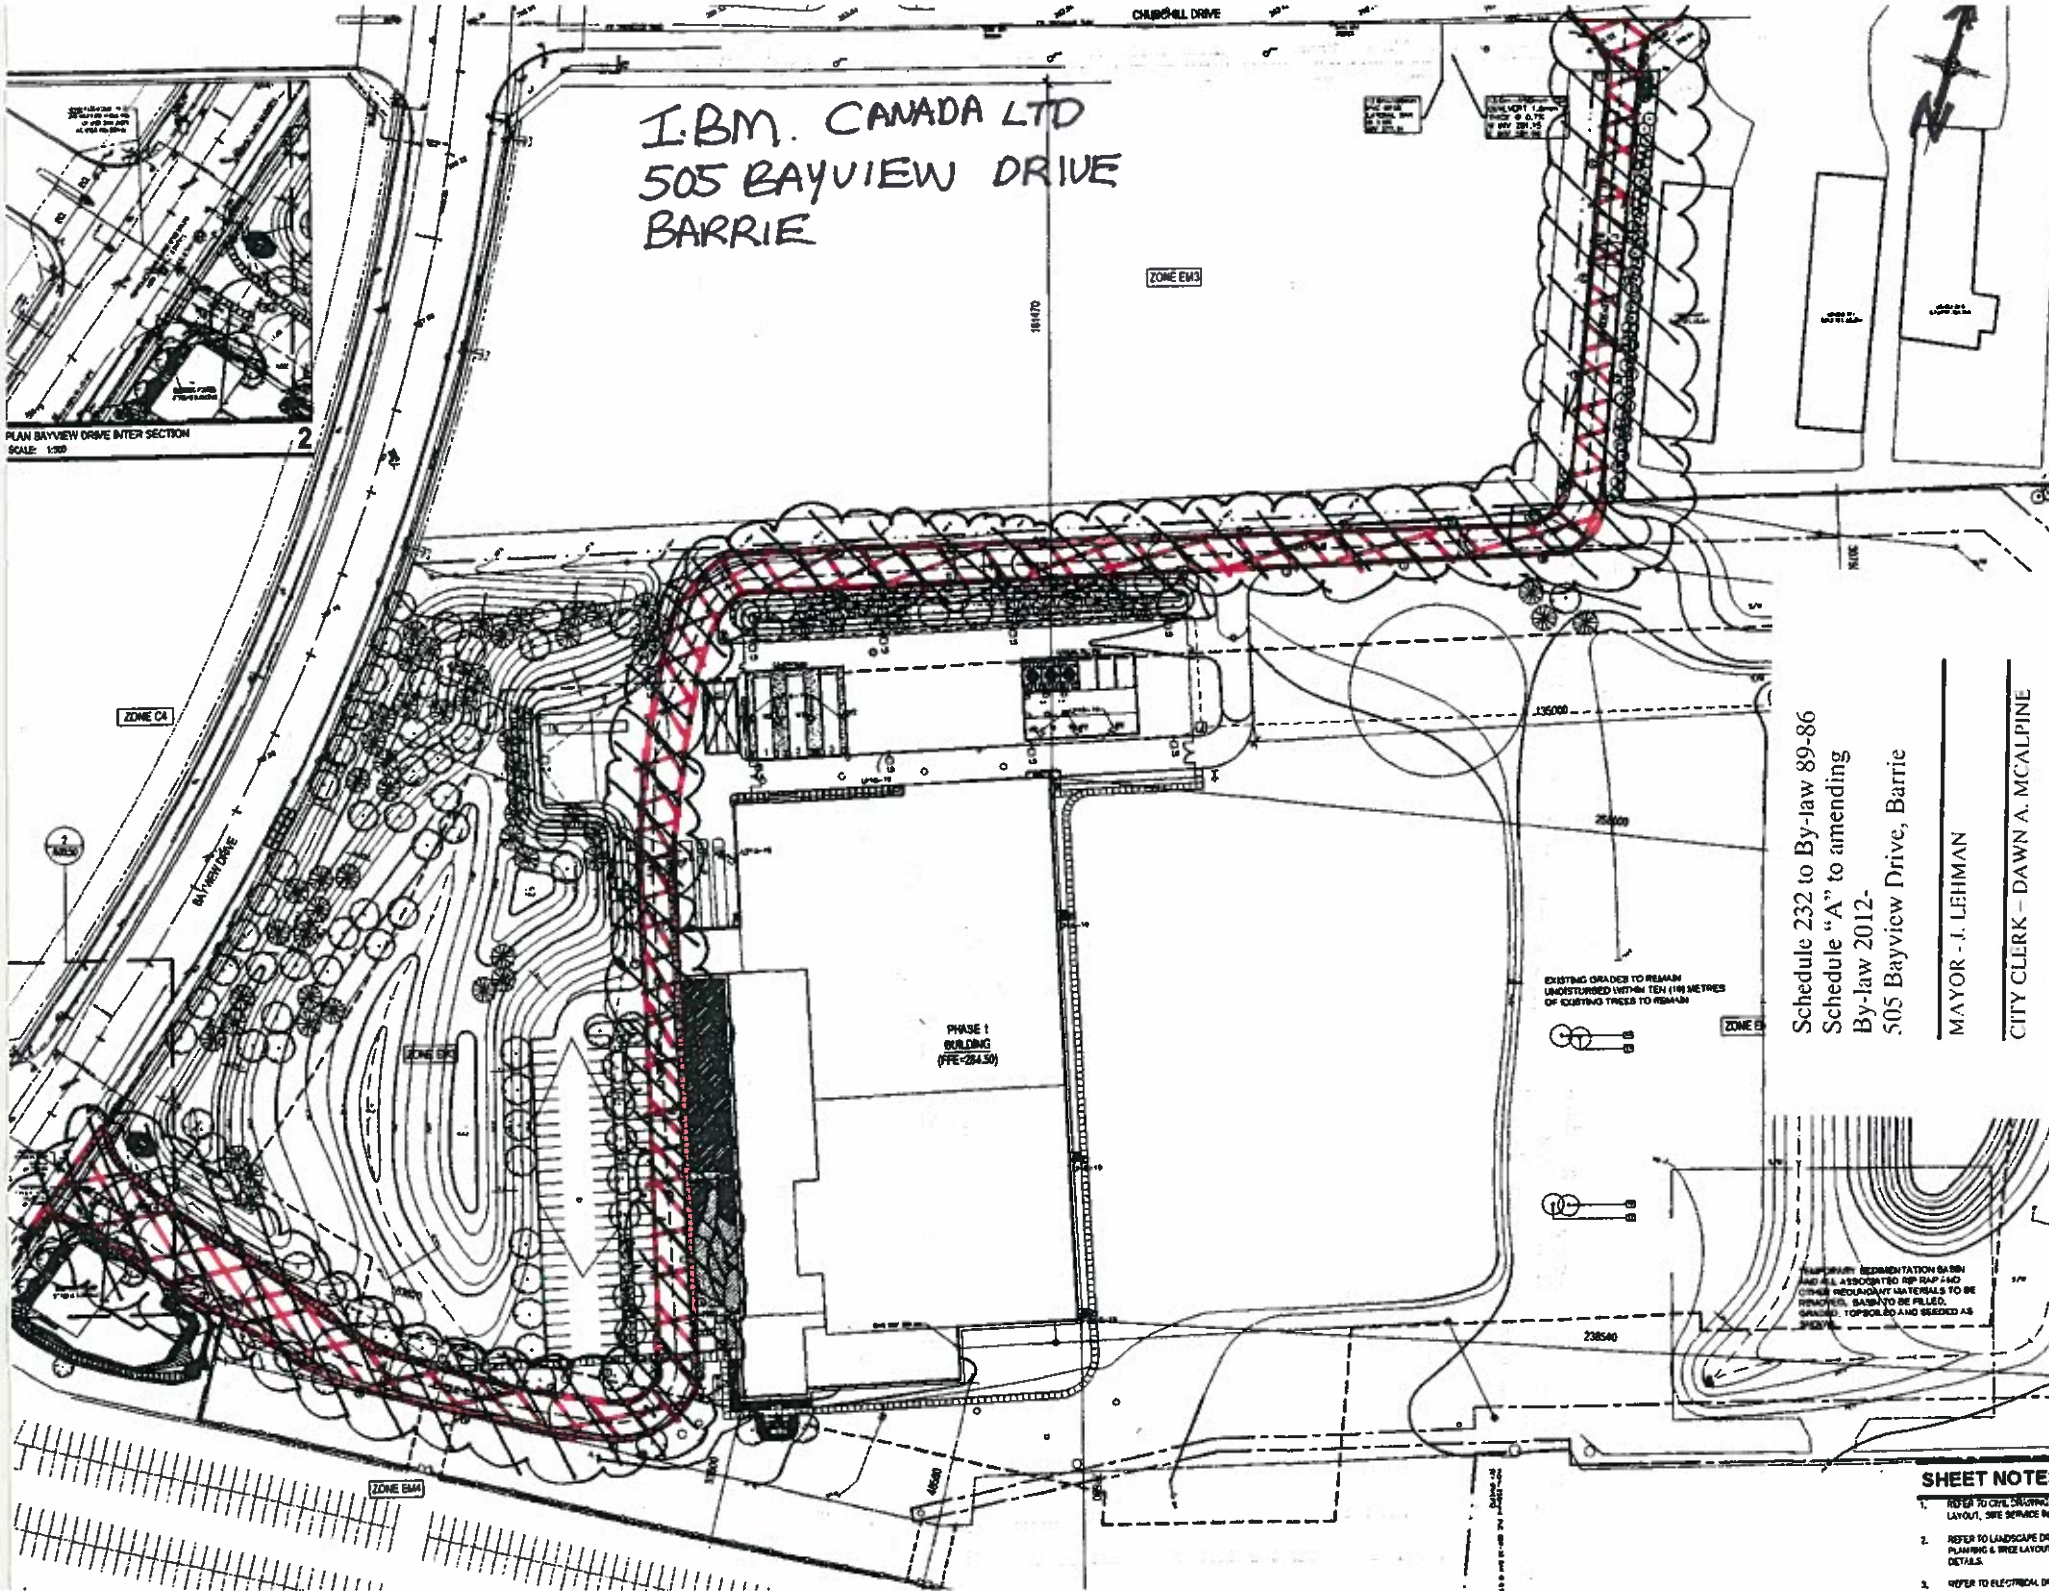

Schedule 232 to By-law 89-86
Schedule "A" to amending
By-law 2012-
505 Bayview Drive, Barrie


MAYOR - J. LEHMAN

CITY CLERK - DAWN A. MCALPINE

SHEET NOTES

1. REFER TO CIVIL ENGINEERING LAYOUT, SITE SERVICE PLAN
2. REFER TO LANDSCAPE DESIGN PLANNING & TREE LAYOUT, DETAILS
3. REFER TO ELECTRICAL PLAN

91 COUGHLIN RD., BARRIE

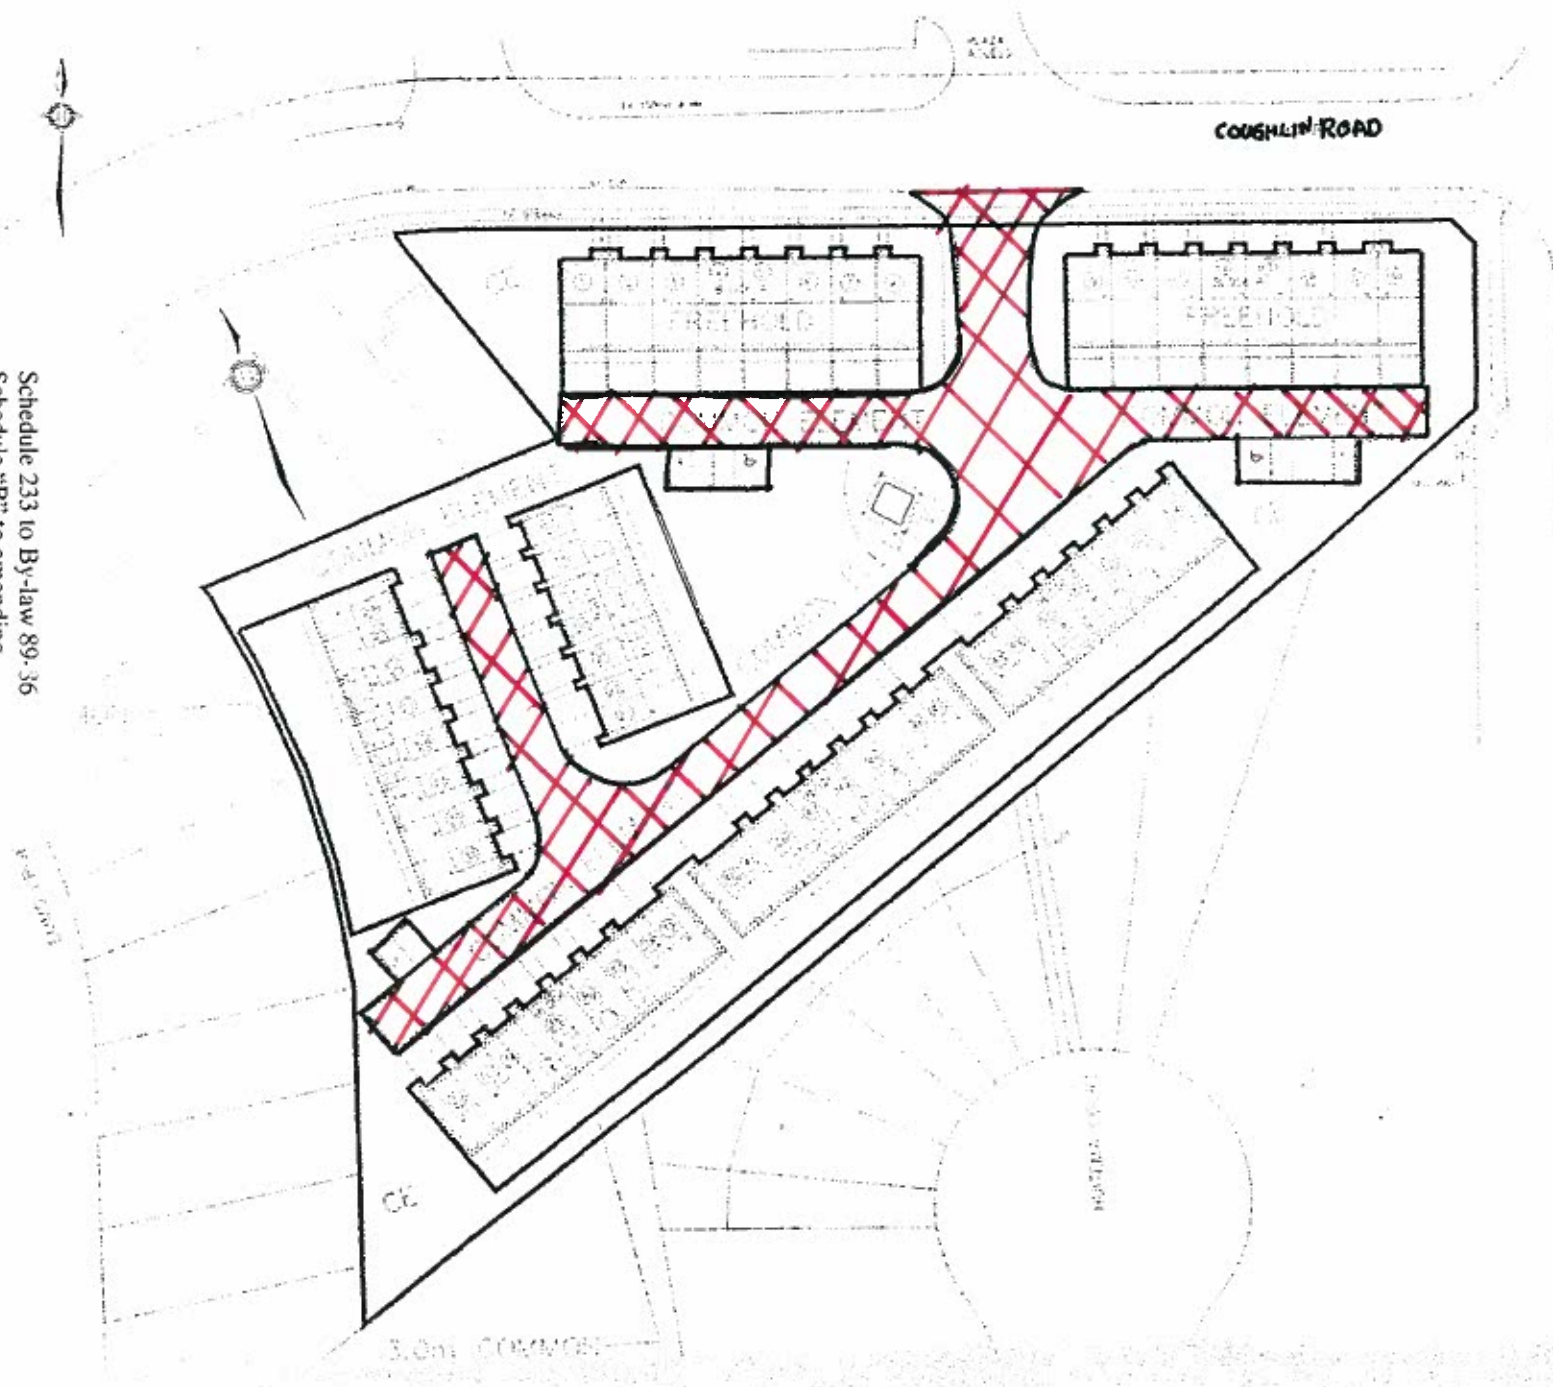

Schedule 233 to By-law 89-36
Schedule "B" to amending
By-law 2012-
91 Coughlin Road, Barrie

MAYOR - J. LEHMAN

CITY CLERK - DAWN A. MCALPINE